

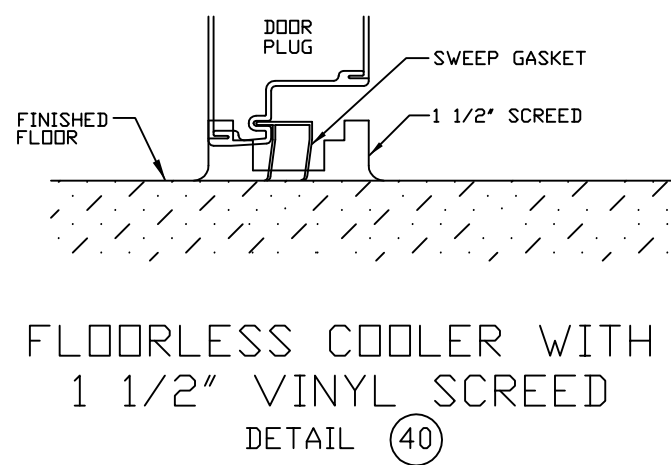
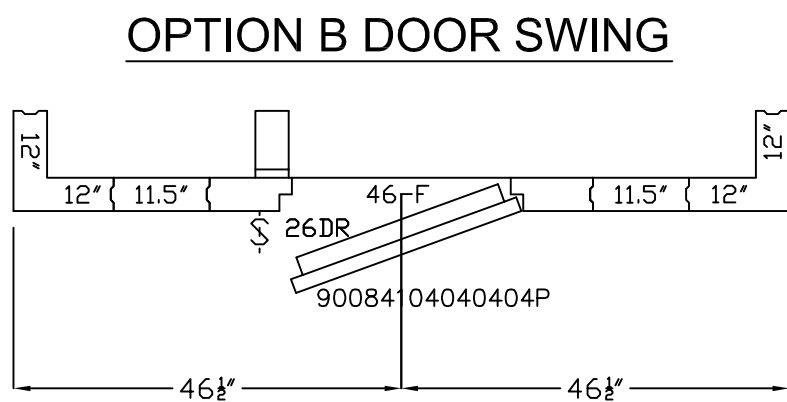
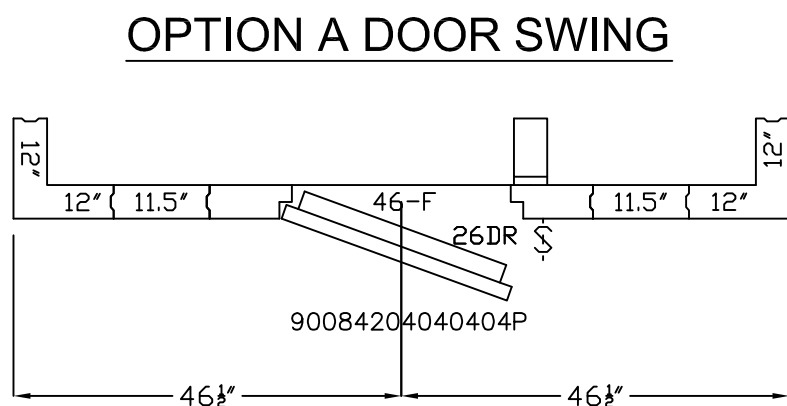
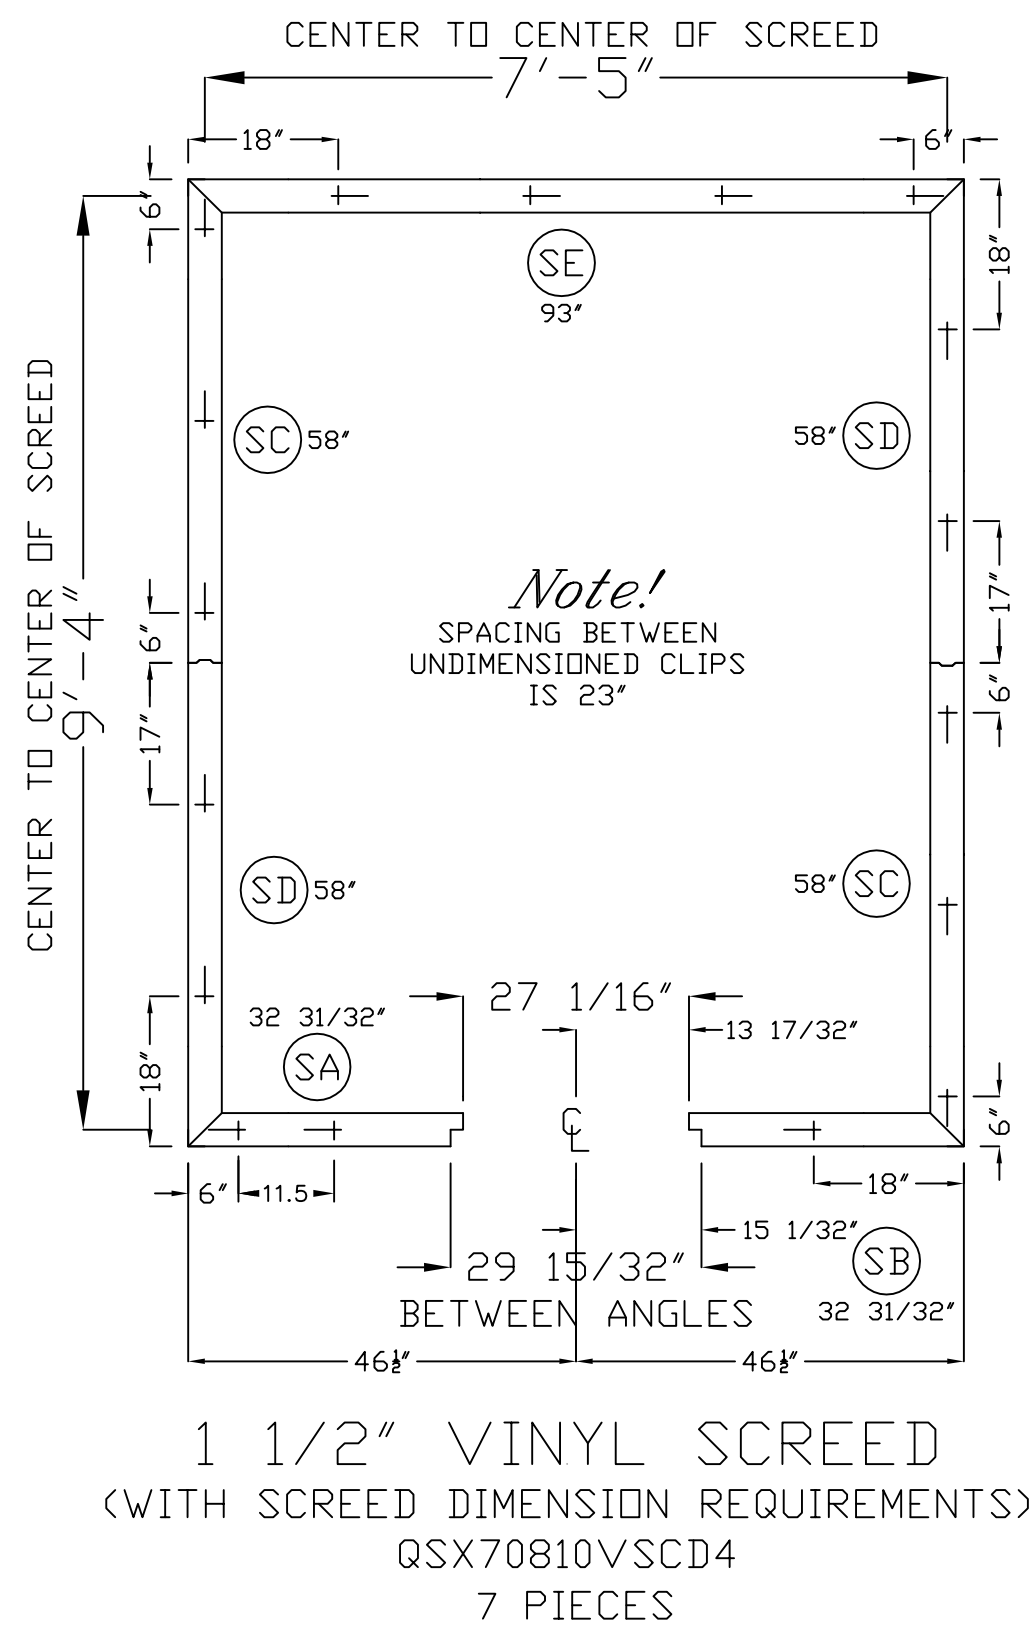


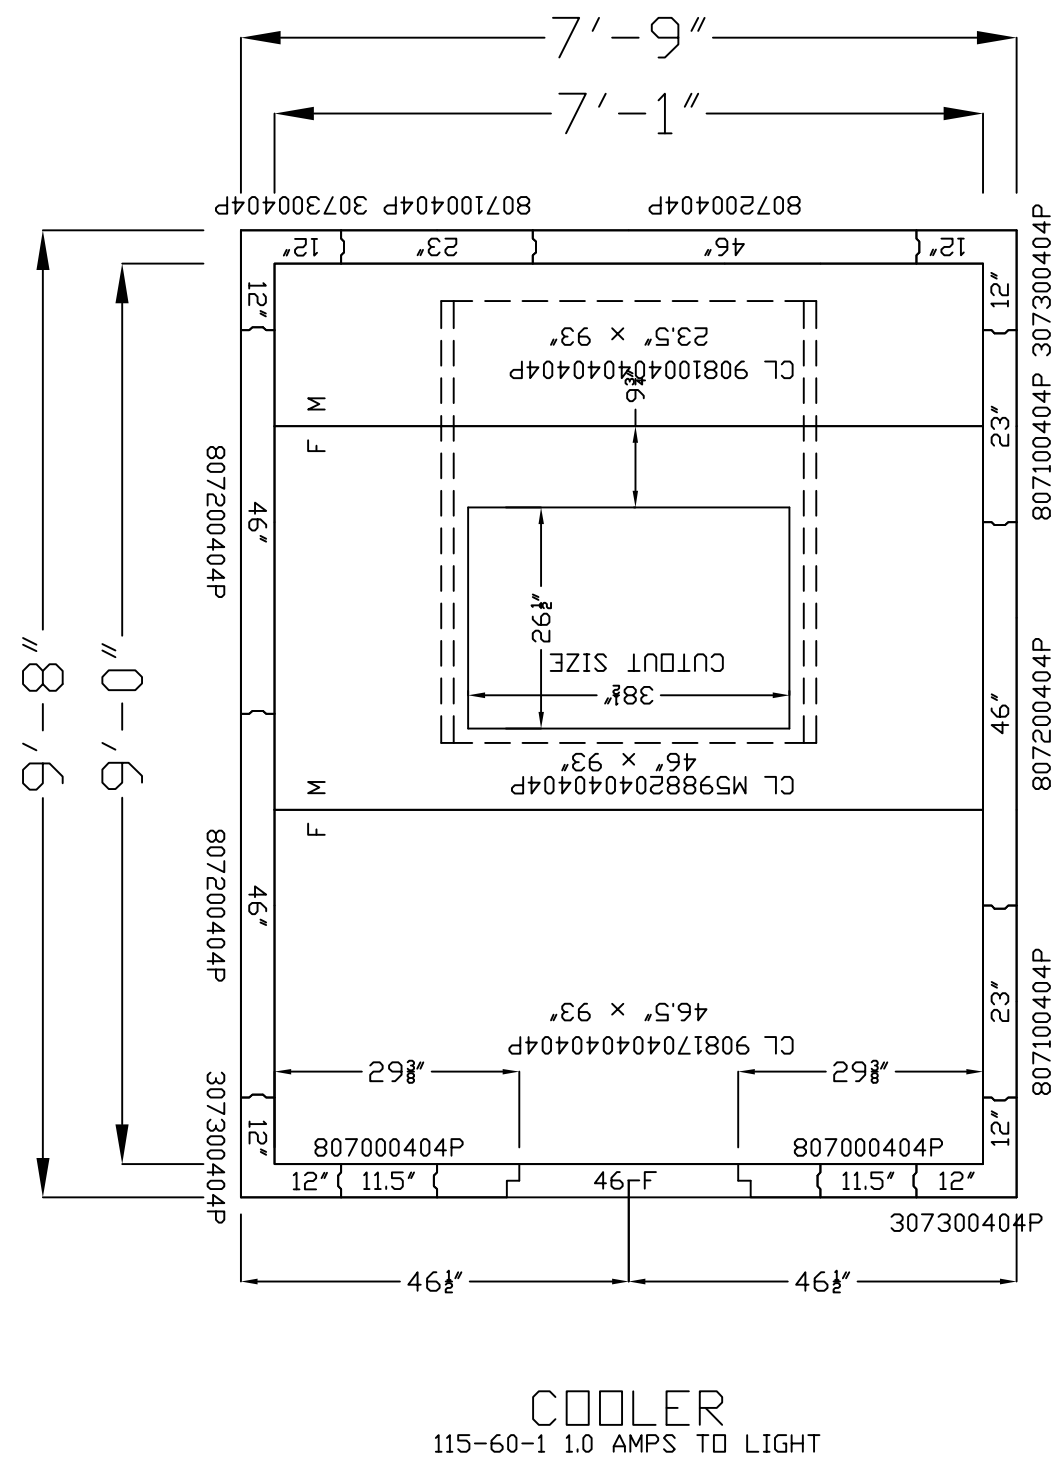

LH SHOWN
RH OPPOSITE

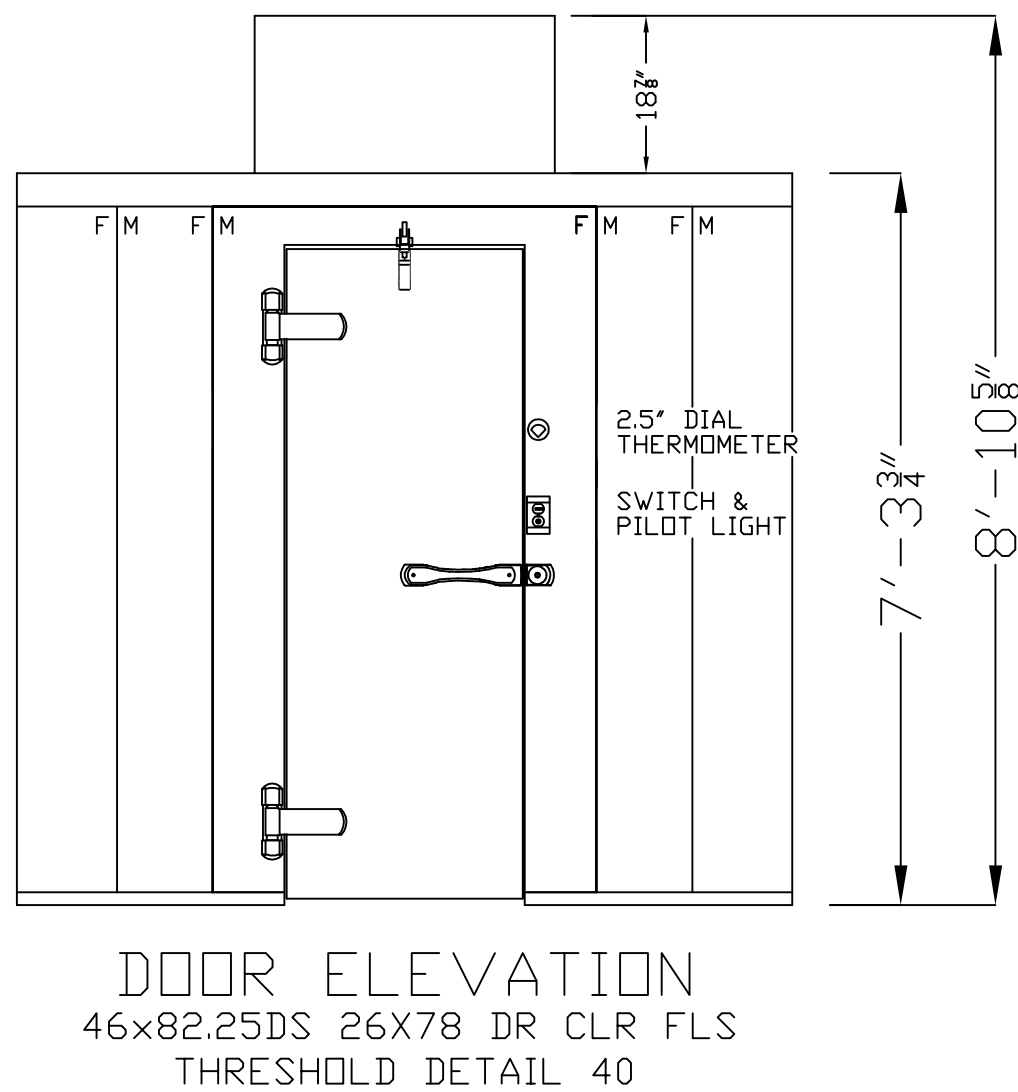

WALK-IN SPECIFICATIONS

SIZE: 7'-9" X 9'-8" X 7'-3 3/4"

PANELS:

ALL FOAMED PANELS ARE 4"

EXTERIOR FINISH:

ALL 26 GA STUCCO GALVALUME

INTERIOR FINISH:

ALL 26 GA STUCCO GALVALUME

FLOOR TYPE:

COOLER - 1 1/2" VINYL SCREED

HEIGHT:

OD 7'-3 3/4" ID 6'-11 3/4"

DOORS:

46x82.25DS 26X78 DR CLR FLS
115-60-1/1.0 AMPS


ACCESSORIES:

(NONE)

REFRIG: POLAR-PAK

OPTION (1) PC069T2 115/60-1 R404A 16.3 AMPS
OPTION (2) PC069T3 208/230/60-1 R404A 6.3 AMPS

USE this drawing for installation

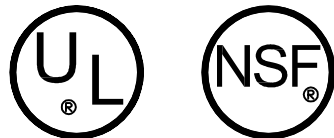

IMPORTANT NOTES:

- 1) ALLOW MINIMUM 1" CLEARANCE ALL AROUND WALK-IN.
- 2) WALK-IN CEILING IS NOT DESIGNED FOR FOOT TRAFFIC OR STORAGE.
- 3) GENERAL CONTRACTOR TO REFER TO DESIGN AND SPECIFICATIONS MANUAL FOR FLOOR DETAIL INFORMATION.
- 4) SPECIAL NOTE TO GENERAL CONTRACTOR AND SUBCONTRACTOR FOR QUARRY TILE OR CONCRETE WEARING FLOOR - THE SHEET METAL PANEL FACINGS MAY BE SUSCEPTABLE TO STAINING DUE TO EXCESSIVE MOISTURE CREATED BY THE HYDRATION OF CONCRETE TYPE MATERIALS. THEREFORE, IT IS ABSOLUTELY NECESSARY THAT EACH ROOM BE PROPERLY VENTILATED. ALSO NOTE THAT SPECIAL PRECAUTIONS MUST BE TAKEN WHEN USING MURIC ACID DUE TO EFFECTS HYDROCHLORIC ACID FUMES HAVE ON ALUMINUM AND STAINLESS STEEL MATERIALS.

KOLPAK
WALK-INS

2915 TENNESSEE AVENUE NORTH
P.O. BOX 550
PARSONS, TN. 38363
(731) 847-6361

DRAWN SB
CHECKED DDC

DEALER:
PROJECT: 7'-9"X9'-8"X7'-3 3/4"

REV. 0 SCALE 3/8"=1'-0"
DATE 05/19/2010

DRAWING NO.
QSX7-0810-CT